

AMERSON WATER TREATMENT PLANT GENERATOR FUEL SYSTEM REPLACEMENT

MACON WATER AUTHORITY (MWA) | 10709-100

703 RIVERBEND RD, MACON,
GA 31211

ISSUE FOR CONSTRUCTION
6/1/2026

PROJECT TEAM

OWNER
MACON WATER AUTHORITY (MWA)
537 HEMLOCK STREET, MACON, GA 31201
CONTACT: HEATHER VEAL, PROJECT MANAGER
T: 478.464.5642
hveal@maconwater.org

CIVIL ENGINEER
TRIPLE POINT ENGINEERING
93 GATEWAY DRIVE, MACON, GA 31210
T: 478.476.0776

STRUCTURAL ENGINEER
PI-TECH, INC.
115 FOREST HILL ROAD, MACON, GA 31210
478.743.5600

MECHANICAL ENGINEER
CLARK NEXSEN
3920 ARKWRIGHT ROAD, MACON, GA 31210
T: 478.743.8415

ELECTRICAL ENGINEER
CLARK NEXSEN
3920 ARKWRIGHT ROAD, MACON, GA 31210
T: 478.743.8415


SHEET LIST		
SHEET NAME	SHEET NUMBER	SHEET DISCIPLINE
TITLE SHEET	GI001	
LEGEND AND GENERAL NOTES	C0.1	CIVIL
TOPOGRAPHIC AND FEATURE SURVEY	C1.0	CIVIL
SITE LAYOUT PLAN	C2.0	CIVIL
GRADING & DRAINAGE PLAN	C3.0	CIVIL
ES&PC PLAN	C4.0	CIVIL
ES&PC DETAILS	C4.1	CIVIL
ES&PC DETAILS	C6.0	CIVIL
GENERAL NOTES AND DETAILS	S101	STRUCTURAL
FOUNDATION PLAN	S102	STRUCTURAL
SECTIONS	S103	STRUCTURAL
INDUSTRIAL LEGEND	D-001	MECHANICAL
DEMOLITION SITE PLAN	DD101	MECHANICAL
FUEL PIPING SITE PLAN	DP101	MECHANICAL
SECTIONS	D-301	MECHANICAL
ENLARGED PLANS	D-401	MECHANICAL
ENLARGED PLANS	D-402	MECHANICAL
DETAILS	D-501	MECHANICAL
DETAILS	D-502	MECHANICAL
DETAILS	D-503	MECHANICAL
DETAILS	D-504	MECHANICAL
DETAILS	D-505	MECHANICAL
DETAILS	D-506	MECHANICAL
DETAILS	D-507	MECHANICAL
DETAILS	D-508	MECHANICAL
SCHEDULES	D-601	MECHANICAL

SHEET LIST		
SHEET NAME	SHEET NUMBER	SHEET DISCIPLINE
PIPING DIAGRAM	D-701	MECHANICAL
ELECTRICAL LEGEND, NOTES, AND ABBREVIATIONS	E-001	ELECTRICAL
ELECTRICAL DEMOLITION SITE PLAN	ED101	ELECTRICAL
ELECTRICAL SITE PLAN	ES101	ELECTRICAL
LOW VOLTAGE POWER RISER DIAGRAM AND SCHEDULES	EP701	ELECTRICAL
P&ID (NEW)	EC101	ELECTRICAL
P&ID (EXISTING)	EC102	ELECTRICAL
FCP-FDS-201 ONE-LINE (EXISTING)	EC103	ELECTRICAL
FCP-FDS-201 WIRING SCHEMATIC (EXISTING)	EC104	ELECTRICAL
DAY TANKS ONE LINE (EXISTING)	EC105	ELECTRICAL
DAY TANKS WIRING SCHEMATIC (EXISTING)	EC106	ELECTRICAL
DAY TANKS TOP VIEW (EXISTING)	EC107	ELECTRICAL
CONTROL SYSTEM I/O TABLE	EC108	ELECTRICAL
CONTROL SYSTEM ARCHITECTURE	EC109	ELECTRICAL

SITE MAP



VICINITY MAP

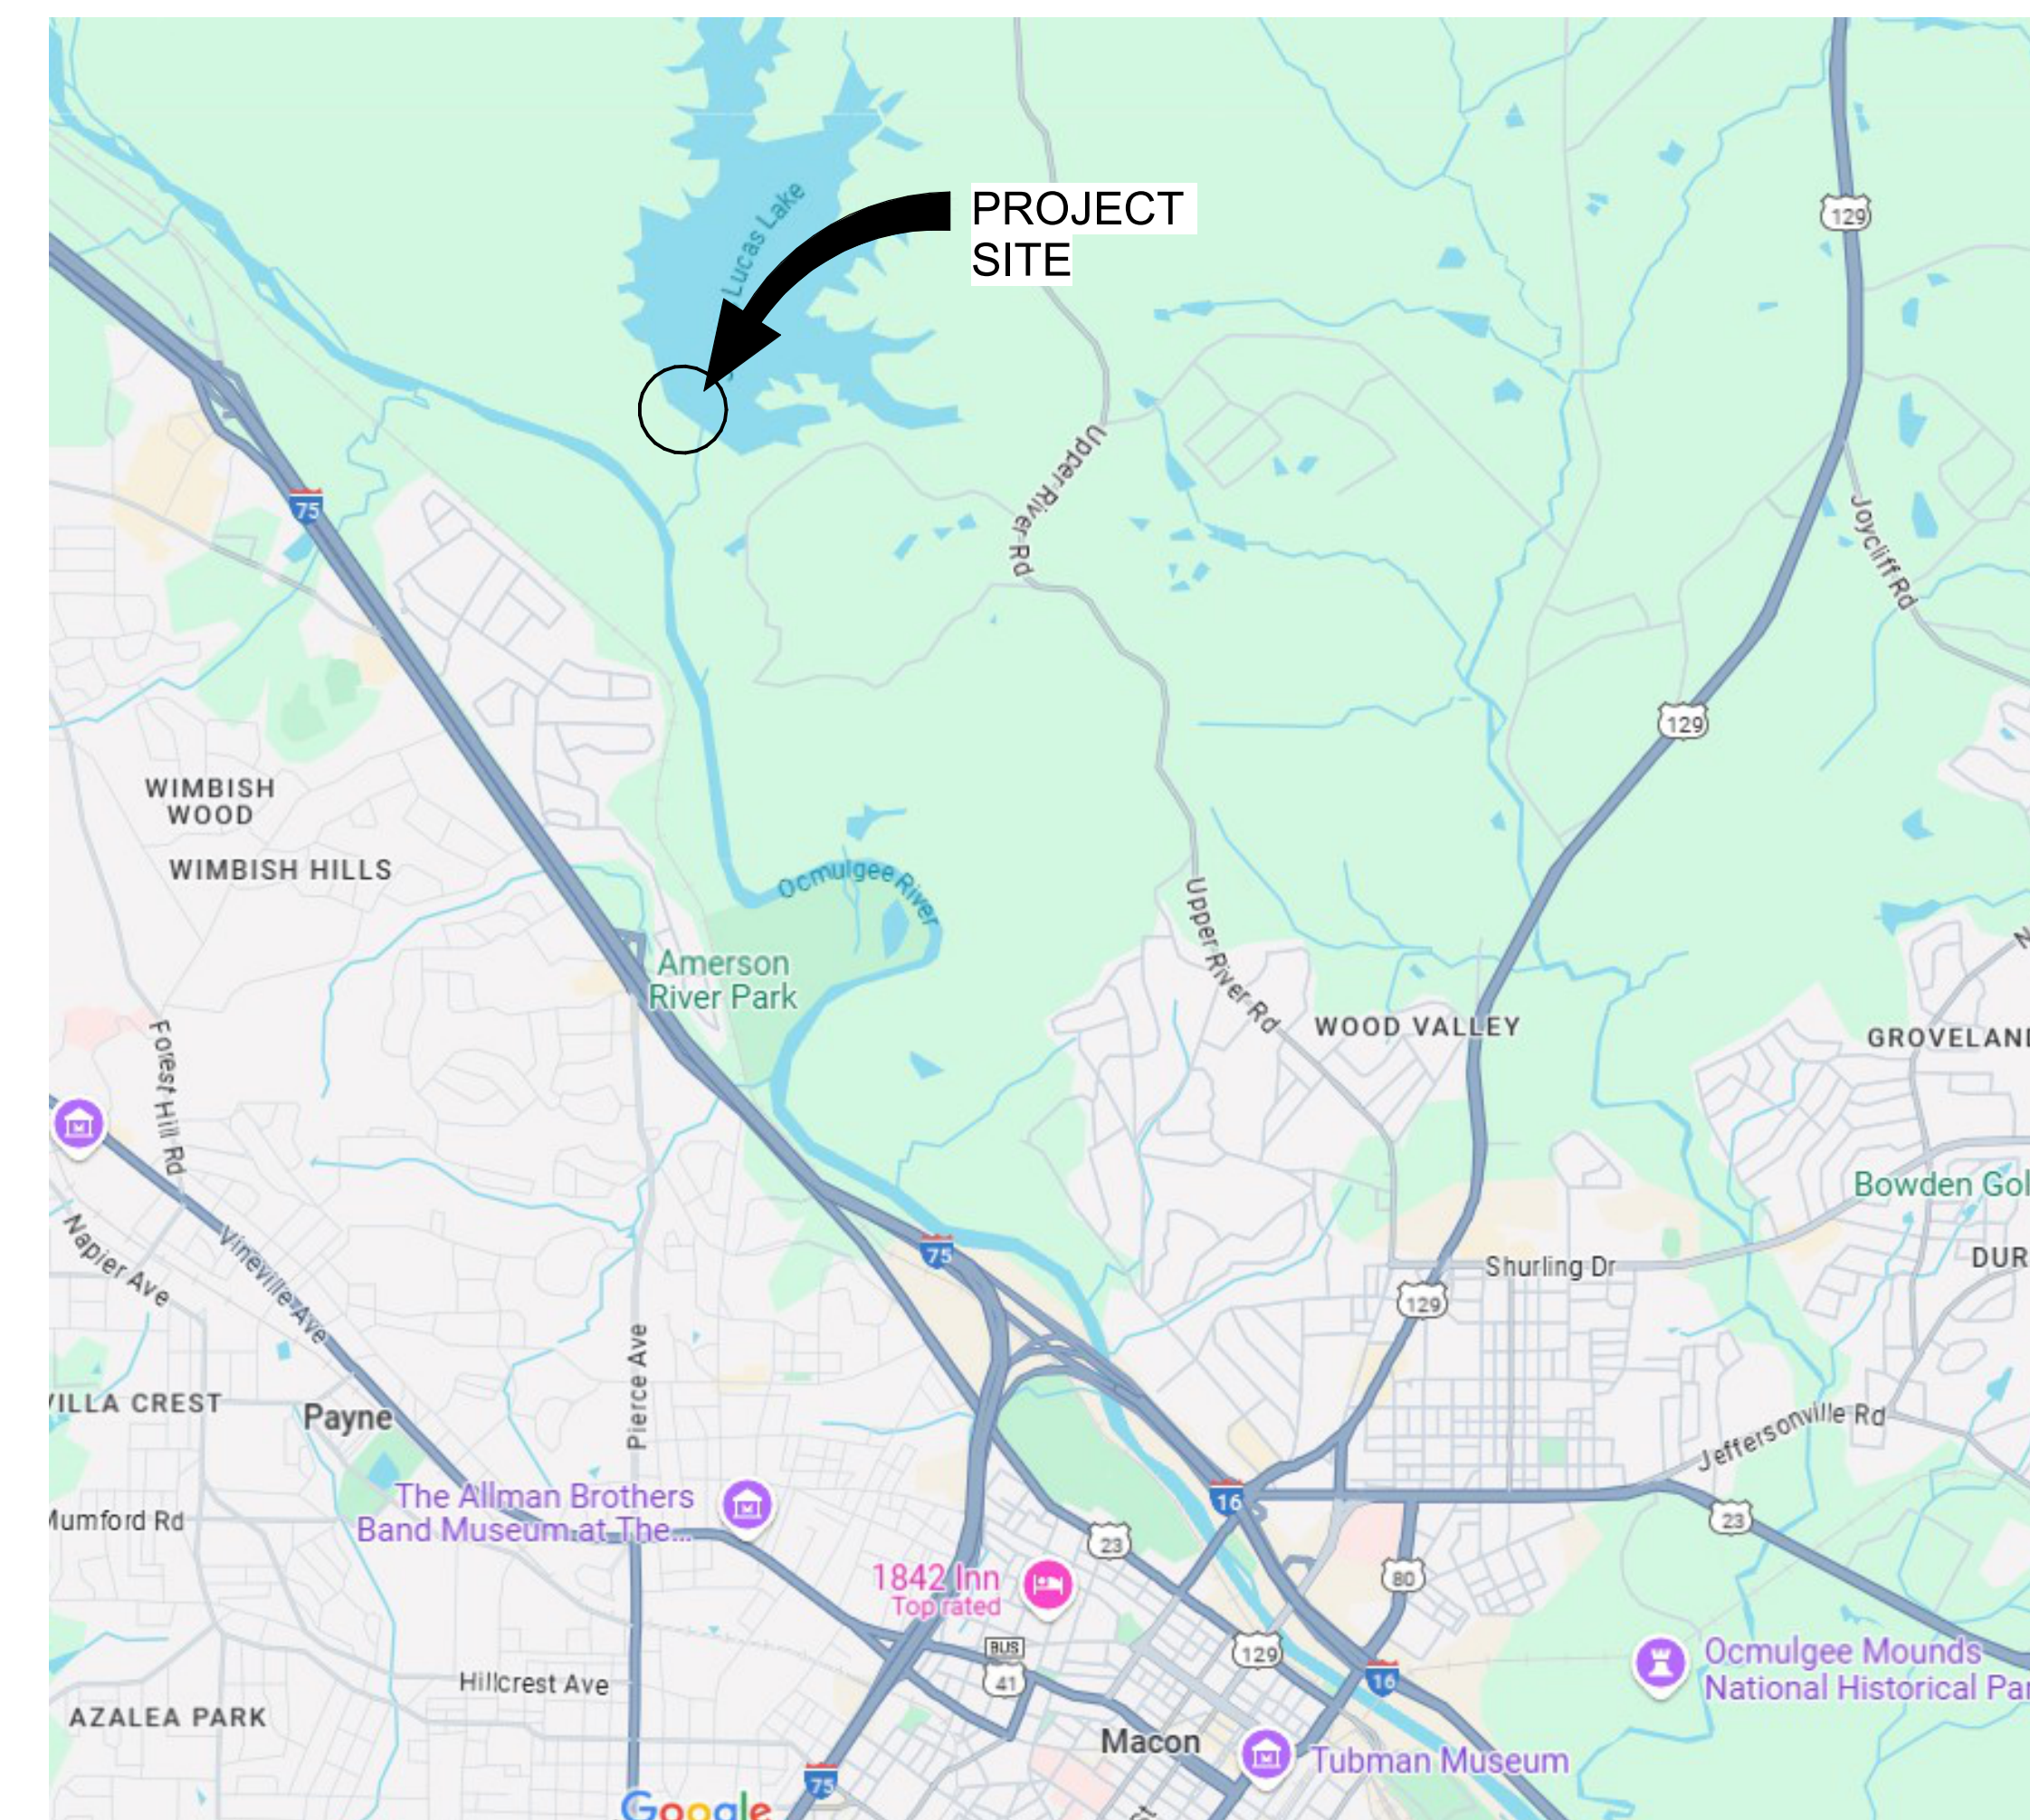

DESIGNER



CLARK NEXSEN

A JMT Company
3920 ARKWRIGHT ROAD SUITE 385
MACON, GEORGIA 31210
478-743-8415

PROFESSIONAL SEAL



SUBMITTAL

6/1/2026

ISSUE FOR CONSTRUCTION

REVISIONS

NO.	DATE	DESCRIPTION

KEY PLAN

SHEET

TITLE SHEET

GI001

DESIGN: RBP
DRAWN: RBP
REVIEW: DKB

CN 10709-100